

COURT ABBOTT ROAD

OSCEOLA STREET

RAILROAD STREET

CLARK HALL ROAD

BOULEVARD STREET


ADAMS STREET

CAMILL STREET

Key To Buildings

- 1 Administration Bldg., Lee Hall
- 2 Jackson Davis Hall
- 3 Dining Hall
- 4 Agricultural Building
- 5 N. B. Young Hall (Boys' Dormitory)
- 6 Mechanic Arts Building
- 7 Carnegie Art Center
- 8 Lucy Moten Demonstration School
- 9 Jones Hall, for men
- 14 Tucker Hall
- 15 Guest House-Alumni Bldg.
- 16 Howard Cottage (Bragg's Res)
- 17 Gliser Cottage
- 18 Weeks' Cottage (Bragg's Res)
- 20 Clark Hall
- 21 Old Hospital
- 22 Melvin Lodge Dormitory
- 23 Mebane Cottage (Paige Management)
- 25 Rhoney's Cottage
- 26 Teacher's Cottage for Women
- 28 Dairy Barn
- 33 Science Hall
- 34 Laundry Buildings, Old
- 34-A Laundry, New
- 35 Rose Economics Building
- 39 Gwynn Cottage
- 40 Publichouse Cottage (Riley's Res)
- 42 President's Residence
- 47 McSwain Dormitory & Diamond Hall
- 48 Sampson Hall for Men
- 49 Coleman Library
- 50 Hanger-Gymnasium
- 51 New Women's Domes (Units A & B)
- 52 Central Heating Plant
- 53 Quonset Building
- 54 New Hospital
- 7-1 Lucy Moten Annex
- 7-2 Band Hall
- 7-3 College Inn

- EXISTING CONDUIT
- EXISTING MANHOLE
- EXISTING CONDUIT
- EXISTING MANHOLE

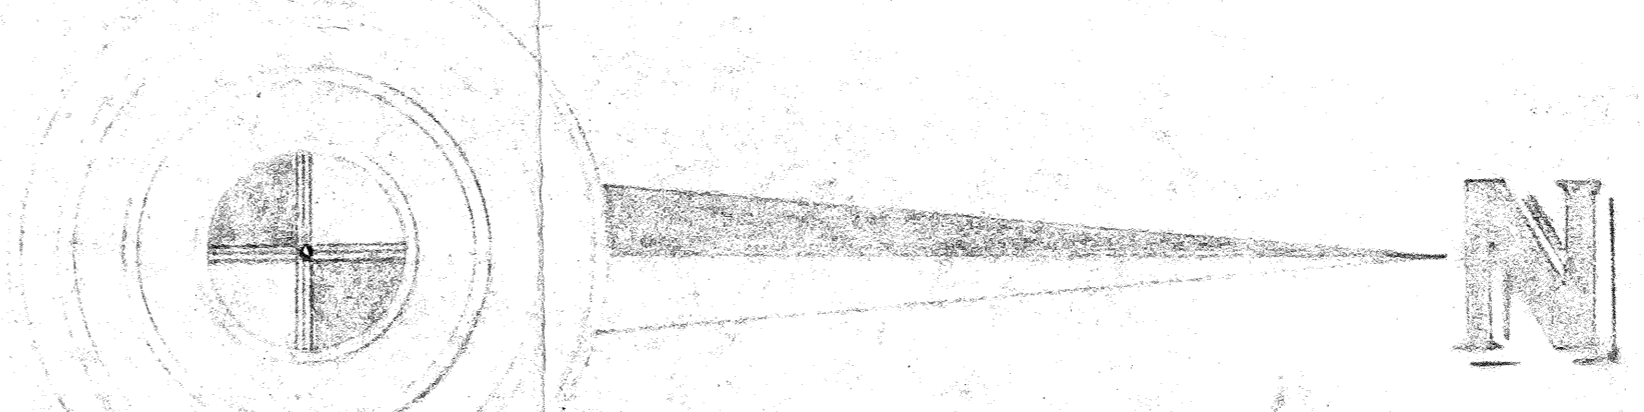

FLORIDA A. & M. COLLEGE CAMPUS					
TALLAHASSEE, FLORIDA					
DATE	REVISIONS.	BY	APP'D	JOB No.	DATE
				105	11-24-50
				DRAWN BY	SCALE
				CHECKED	1
				APP'D	
MECHANICAL DRAWING DEPT. RM. 203 MECH. ARTS BLDG.					

A D A M S S T R E E T